 

 






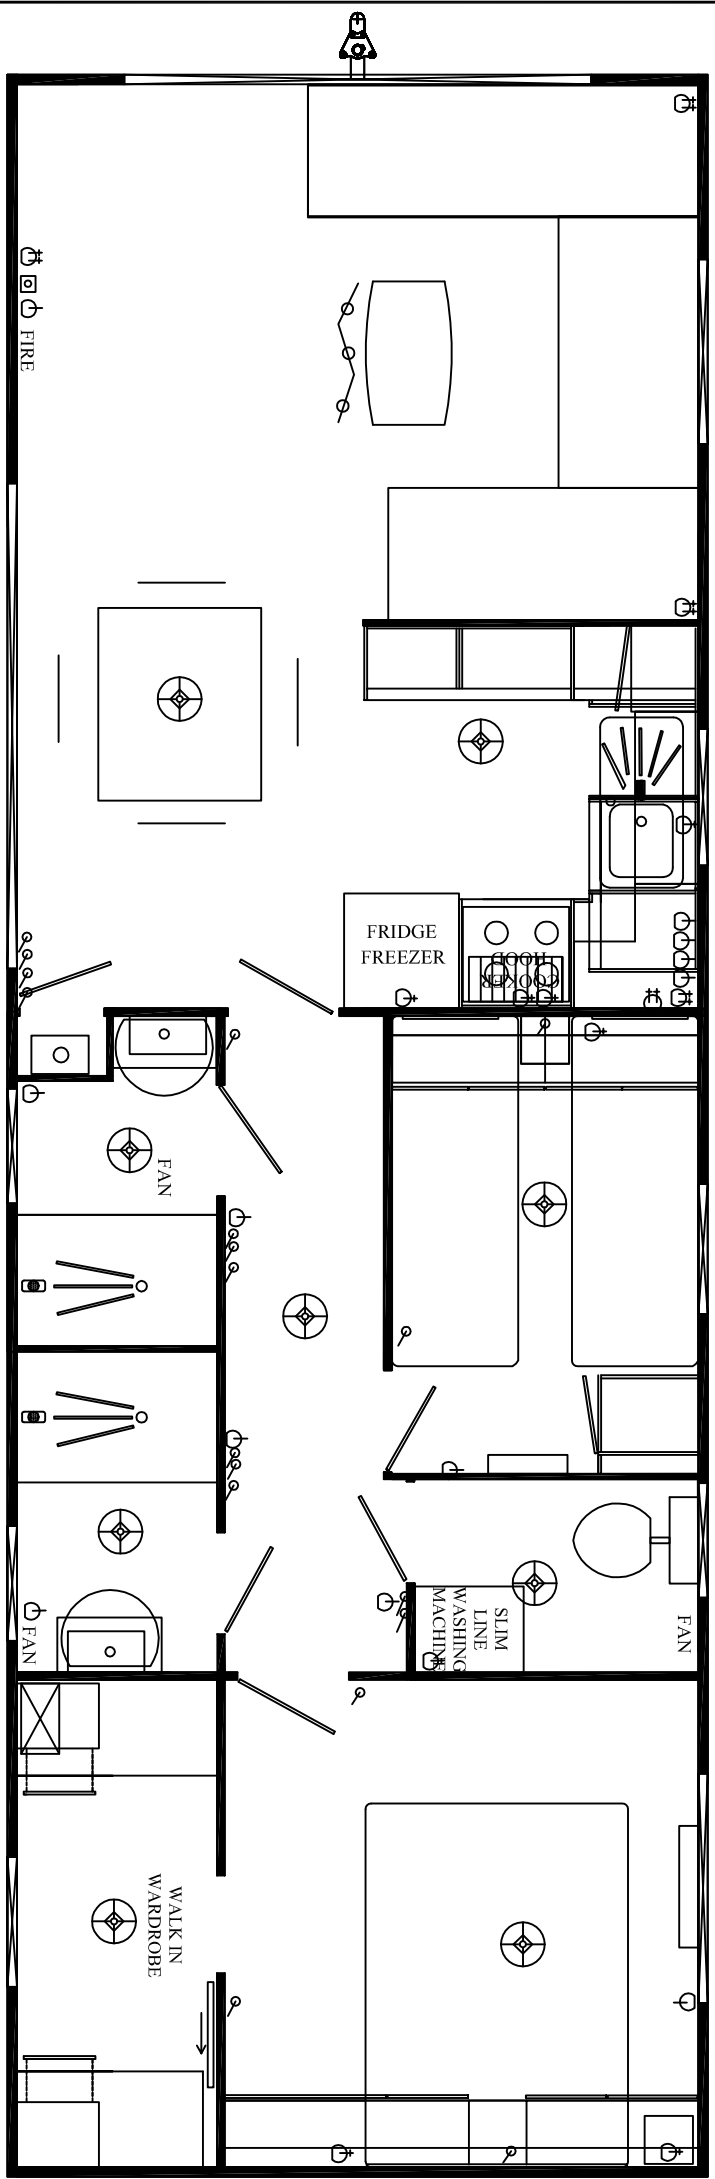


- KEY:
-  DOUBLE SOCKET
  -  SINGLE SOCKET
  -  FUSED SPUR
  -  SWITCH
  -  CEILING LIGHT
  -  RCD MAINS BOX
  -  LIGHT SWITCH
  -  ARIEL POINT
  -  S-TRACK



<b>Amendments</b>	
-------------------	--



Normandy Caravans Ltd  
 Bonhoff Avenue  
 Kingston Upon Hull  
 HU5 4HF  
 England GB  
 Tel: +44(0)1482 475100  
 Fax: +44(0)1482 494301  
 www.normandy-caravans.co.uk

<b>Additional notes:</b> Electrical layout	<b>Drawn by:</b> D.Stamp
--	--------------------------

	<b>Date:</b> 7/4/11
	<b>Title:</b> Deauville 36 x 12 2 bed